



ELECTRICAL LEGEND			
⊞	SWITCH	⊞	FLOODLIGHT
⊞	THREE-WAY SWITCH	⊞	VENT
⊞	FOUR-WAY SWITCH	⊞	VENT AND LIGHT
⊞	DUPLEX	⊞	UNDER CAB. LIGHT
⊞	GFI DUPLEX	⊞	FLOURESCENT LIGHT
⊞	COUNTERTOP DUPLEX	⊞	FAN
⊞	VAPOUR PROOF LIGHT	⊞	PENDANT
⊞	SMOKE DETECTOR	⊞	
⊞	CABLE		
⊞	PHONE OUTLET		
⊞	TV OUTLET		
⊞	CEILING LIGHT		
⊞	RECESSED CEILING LIGHT		
⊞	WALL HUNG LIGHT		

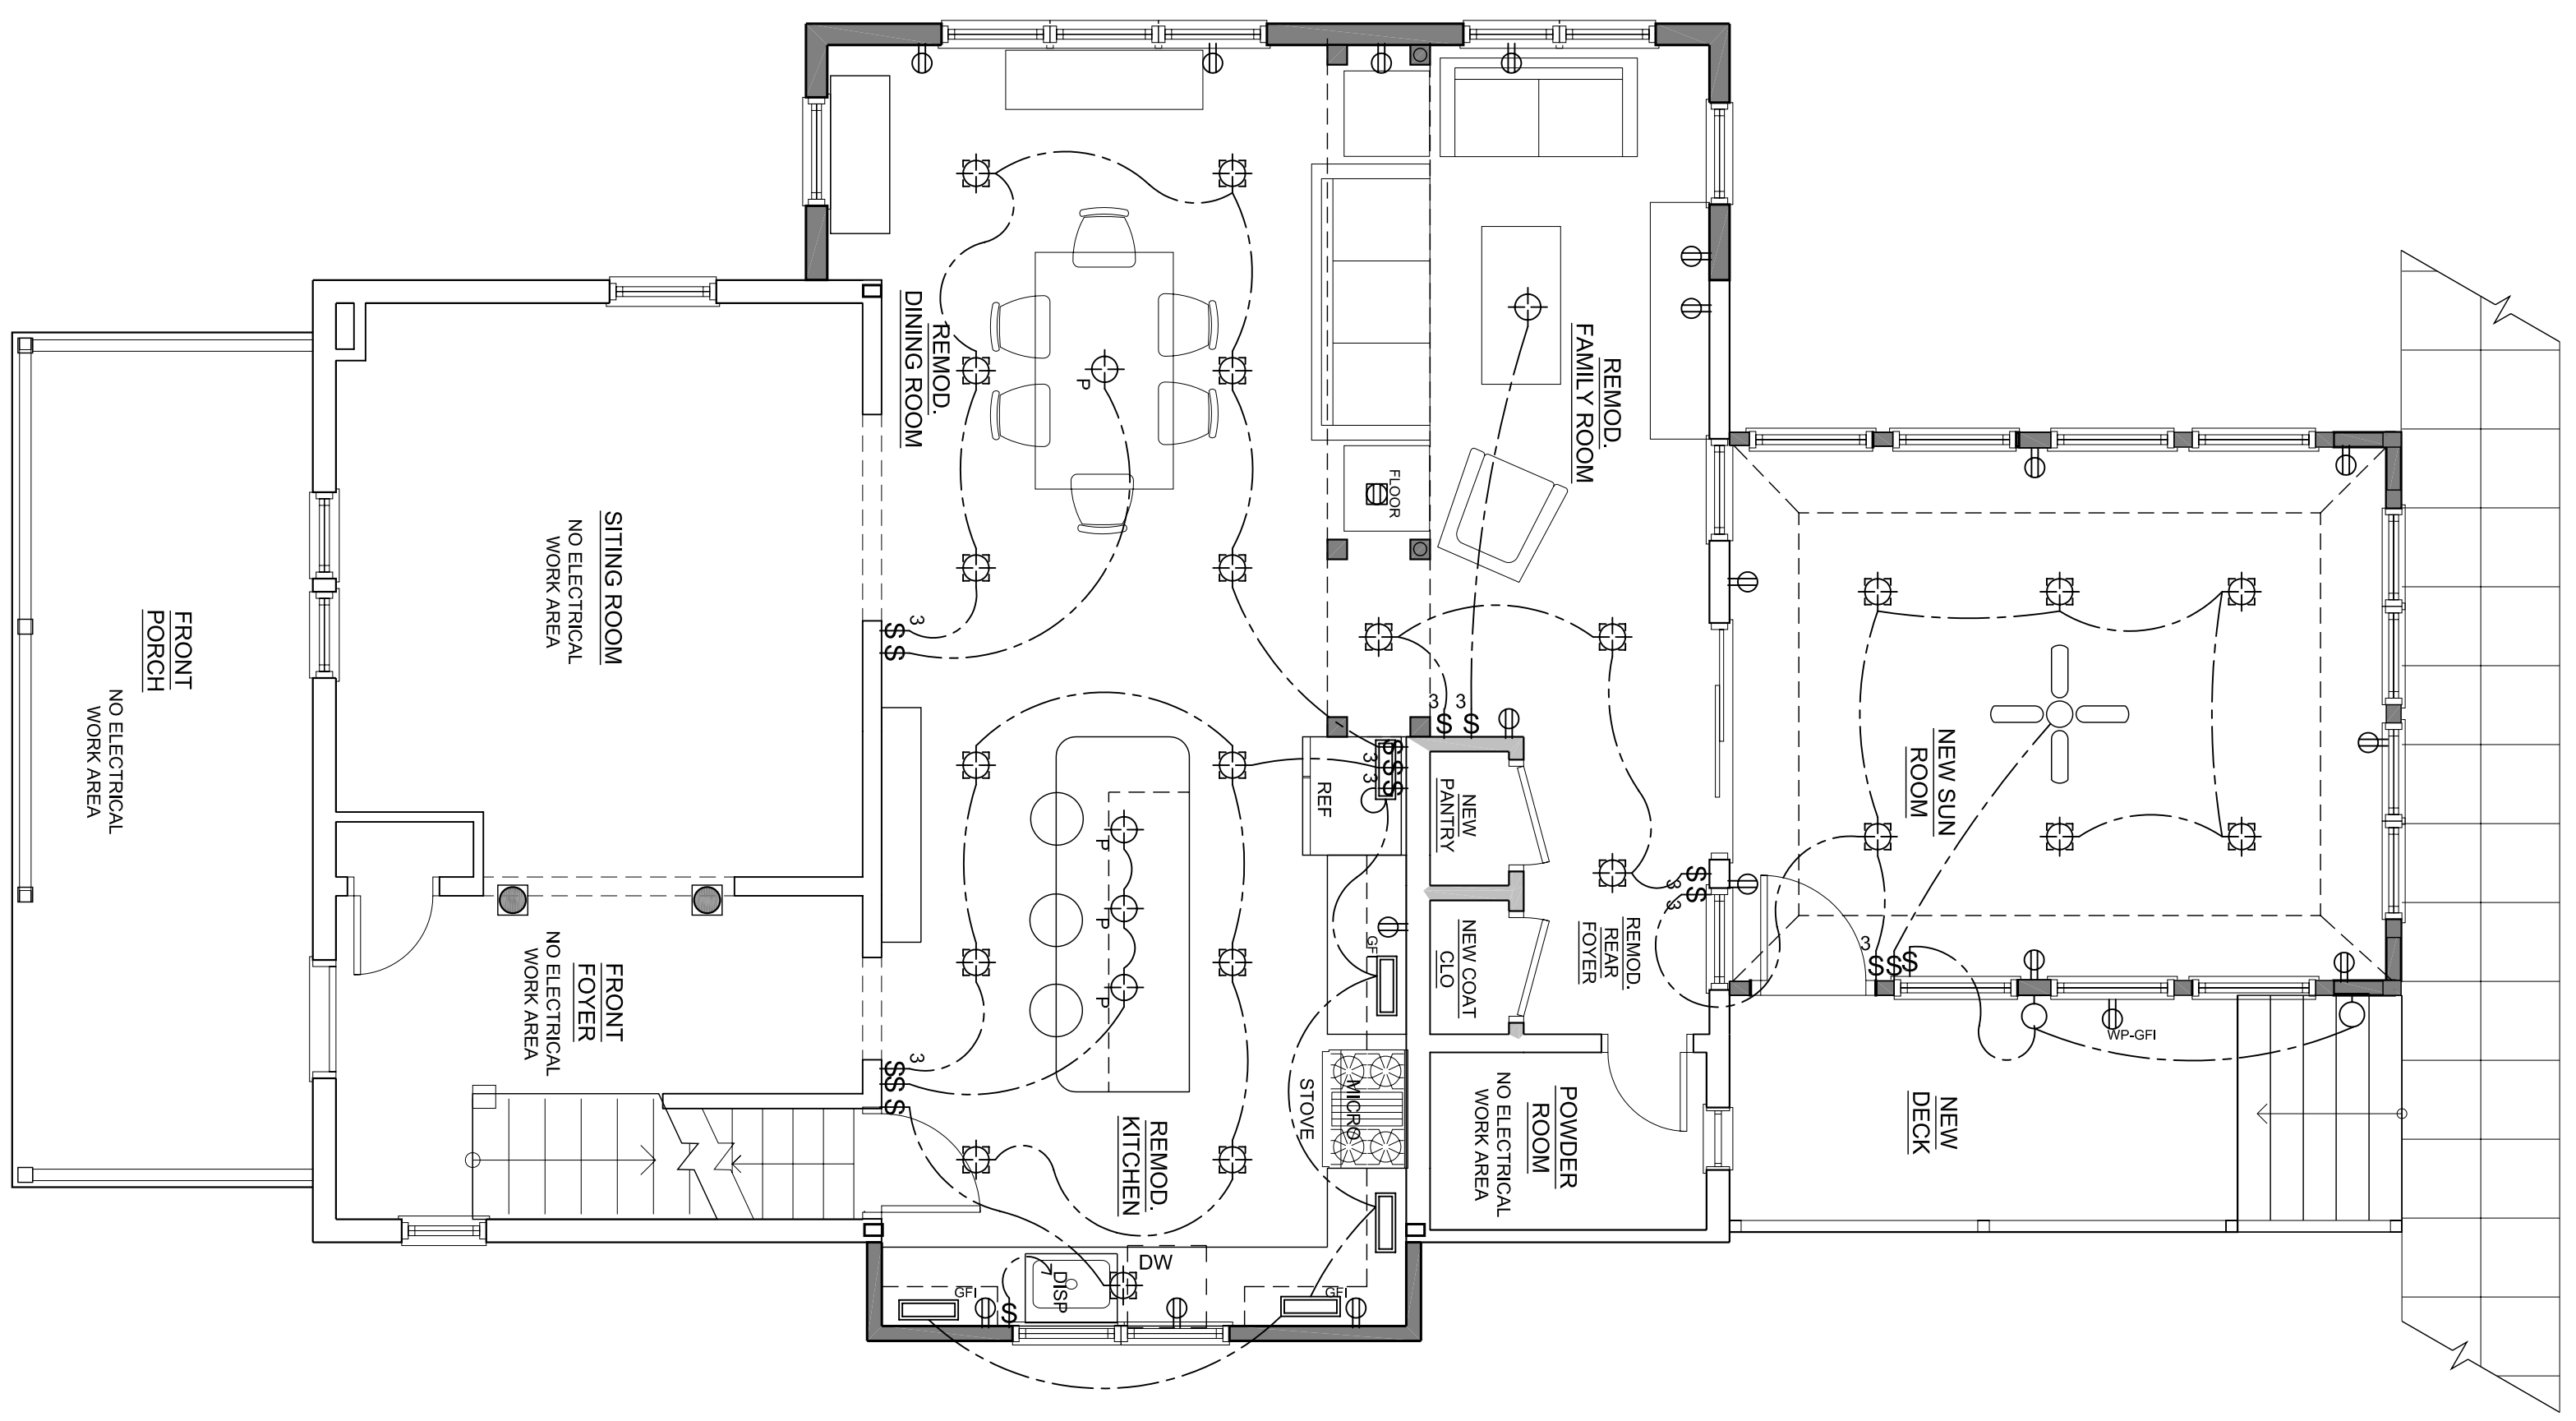

2 PROPOSED ELECTRICAL FIRST FLOOR PLAN  
1/4" = 1'-0"

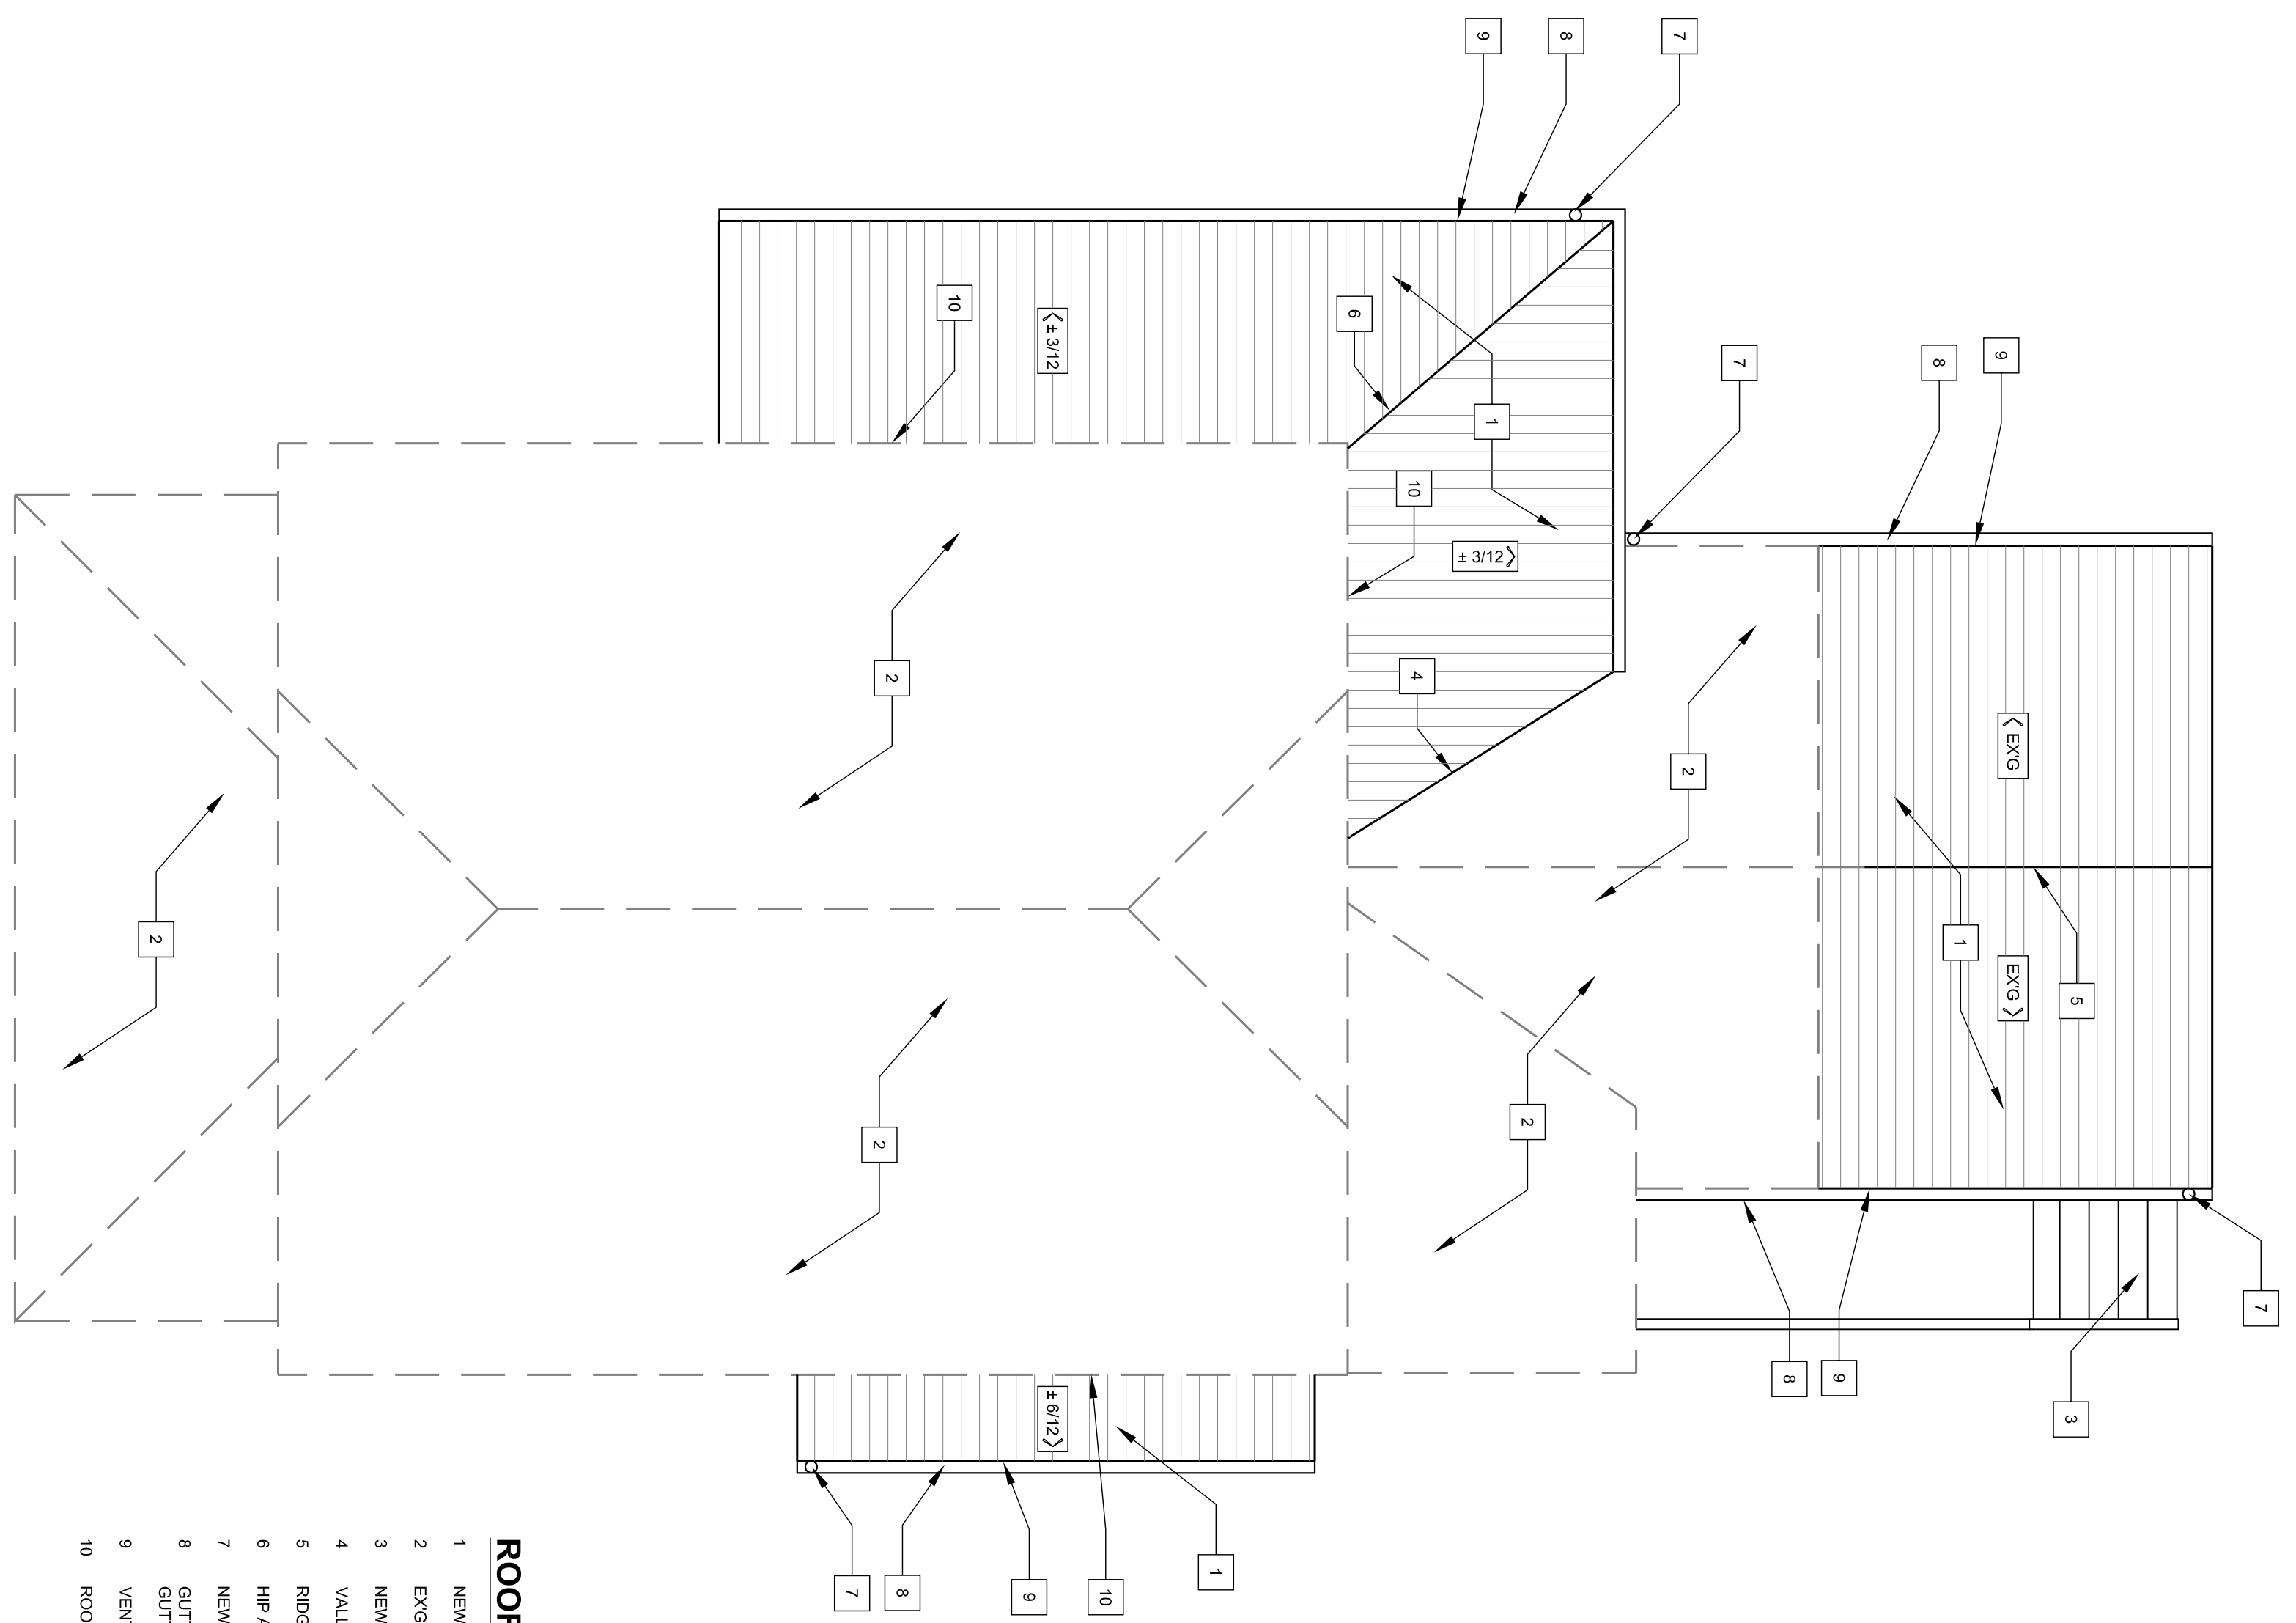

1 ROOF PLAN  
1/4" = 1'-0"

- ROOF PLAN NOTES:**
- 1 NEW ROOF- SHINGLES P/S
  - 2 EXG ROOF- TO REMAIN
  - 3 NEW W/D STEPS
  - 4 VALLES/ S AS NEEDED
  - 5 ROGE LINE W/ RIDGE VENT AS REQ'D
  - 6 HIP AS NEEDED
  - 7 NEW SPOUT LOCATION, SPOUTS P/S
  - 8 GUTTERS P/S, SEE ELEVATIONS FOR ADDITIONAL.
  - 9 VENTED SOFFIT
  - 10 ROOF TO WALL VENT SYSTEM

ALL CONDITIONS AND DIMENSIONS CONTAINED HEREIN ARE APPROXIMATE. ALL TRADES PERSONS INVOLVED WITH THE WORK MUST FIELD VERIFY ALL PERTINENT INFORMATION, CONDITIONS AND DIMENSIONS. SEE SITE DIFFERENCES SHALL BE BROUGHT TO THE ATTENTION OF MC DESIGN BUILD, LLC, THE BUILDER AND THE PROPERTY OWNER. INFORMATION SHOWN ON THIS DOCUMENT INCORPORATES PROPRIETARY RIGHTS AND IS NOT TO BE DUPLICATED WHOLLY OR IN PART WITHOUT THE EXPRESS PERMISSION OF MC DESIGN BUILD, LLC. DO NOT SCALE DRAWINGS

PHASE	DATE
EXG CONDITIONS	6-24-09
PRICE SET	10-28-09
PERMIT REVIEW	12-17-09
PERMIT SET	

SHEET SCALE  
X-1'-0"  
OR AS NOTED

ROOF PLAN AND ELECTRICAL PLAN

SHEET NUMBER  
**A-2.0**  
OF TOTAL

PROJECT TITLE  
**MICHAEL & SYDEL  
CAVANAUGH RESIDENCE**  
6 GEORGE STREET  
GAITHERSBURG, MD 20877  
MONTGOMERY COUNTY

DESIGN  
**MC DESIGN BUILD, LLC**  
6 GEORGE STREET  
GAITHERSBURG, MD 20877  
OFFICE: 301-527-0700 FAX: 301-461-8644

