



ELECTRICAL LEGEND					
\$	SWITCH	☼	SMOKE DETECTOR	☼	FLOODLIGHT
\$	THREE-WAY SWITCH	☼	CABLE	☼	VENT
\$	FOUR-WAY SWITCH	☼	PHONE OUTLET	☼	VENT AND LIGHT
⊕	DUPLEX	☼	TV OUTLET	☼	UNDER CAB. LIGHT
⊕	GF DUPLEX	☼	CEILING LIGHT	☼	FLUORESCENT LIGHT
⊕	COUNTERTOP DUPLEX	☼	RECESSED CEILING LIGHT	☼	FAN
⊕	VAPOUR PROOF LIGHT	☼	WALL HUNG LIGHT	☼	PENDANT

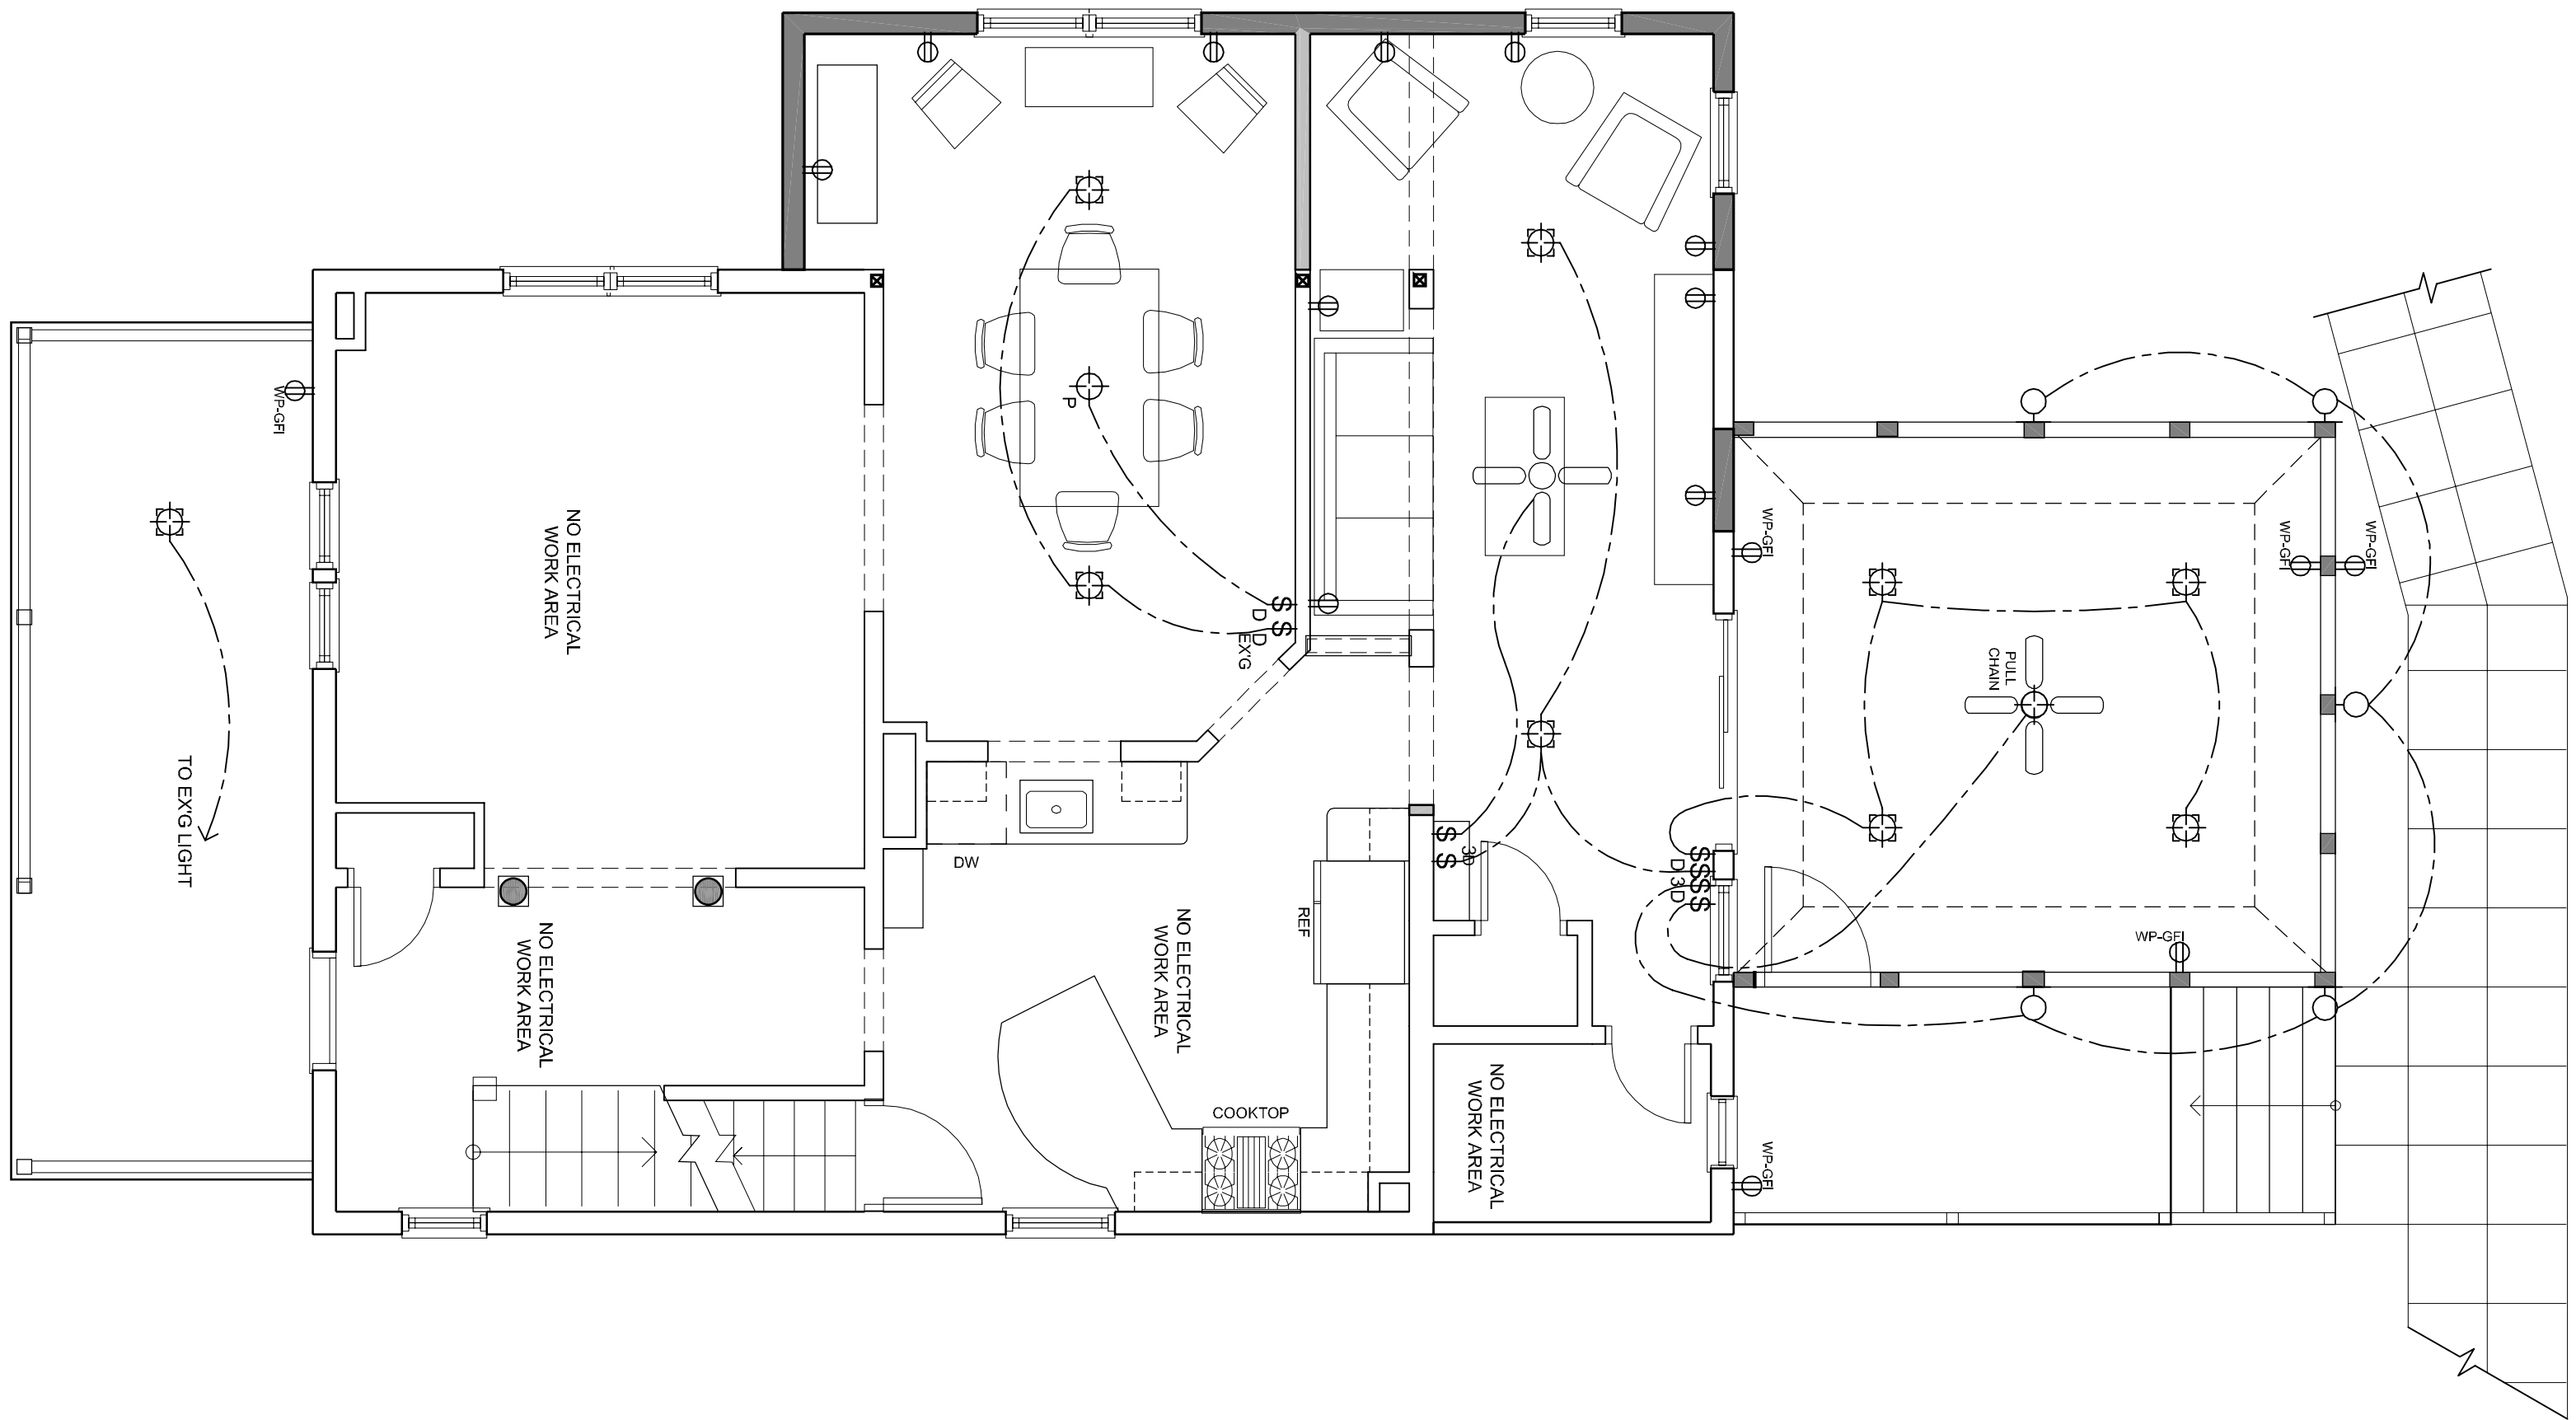

2 PROPOSED ELECTRICAL FIRST FLOOR PLAN
1/4" = 1'-0"

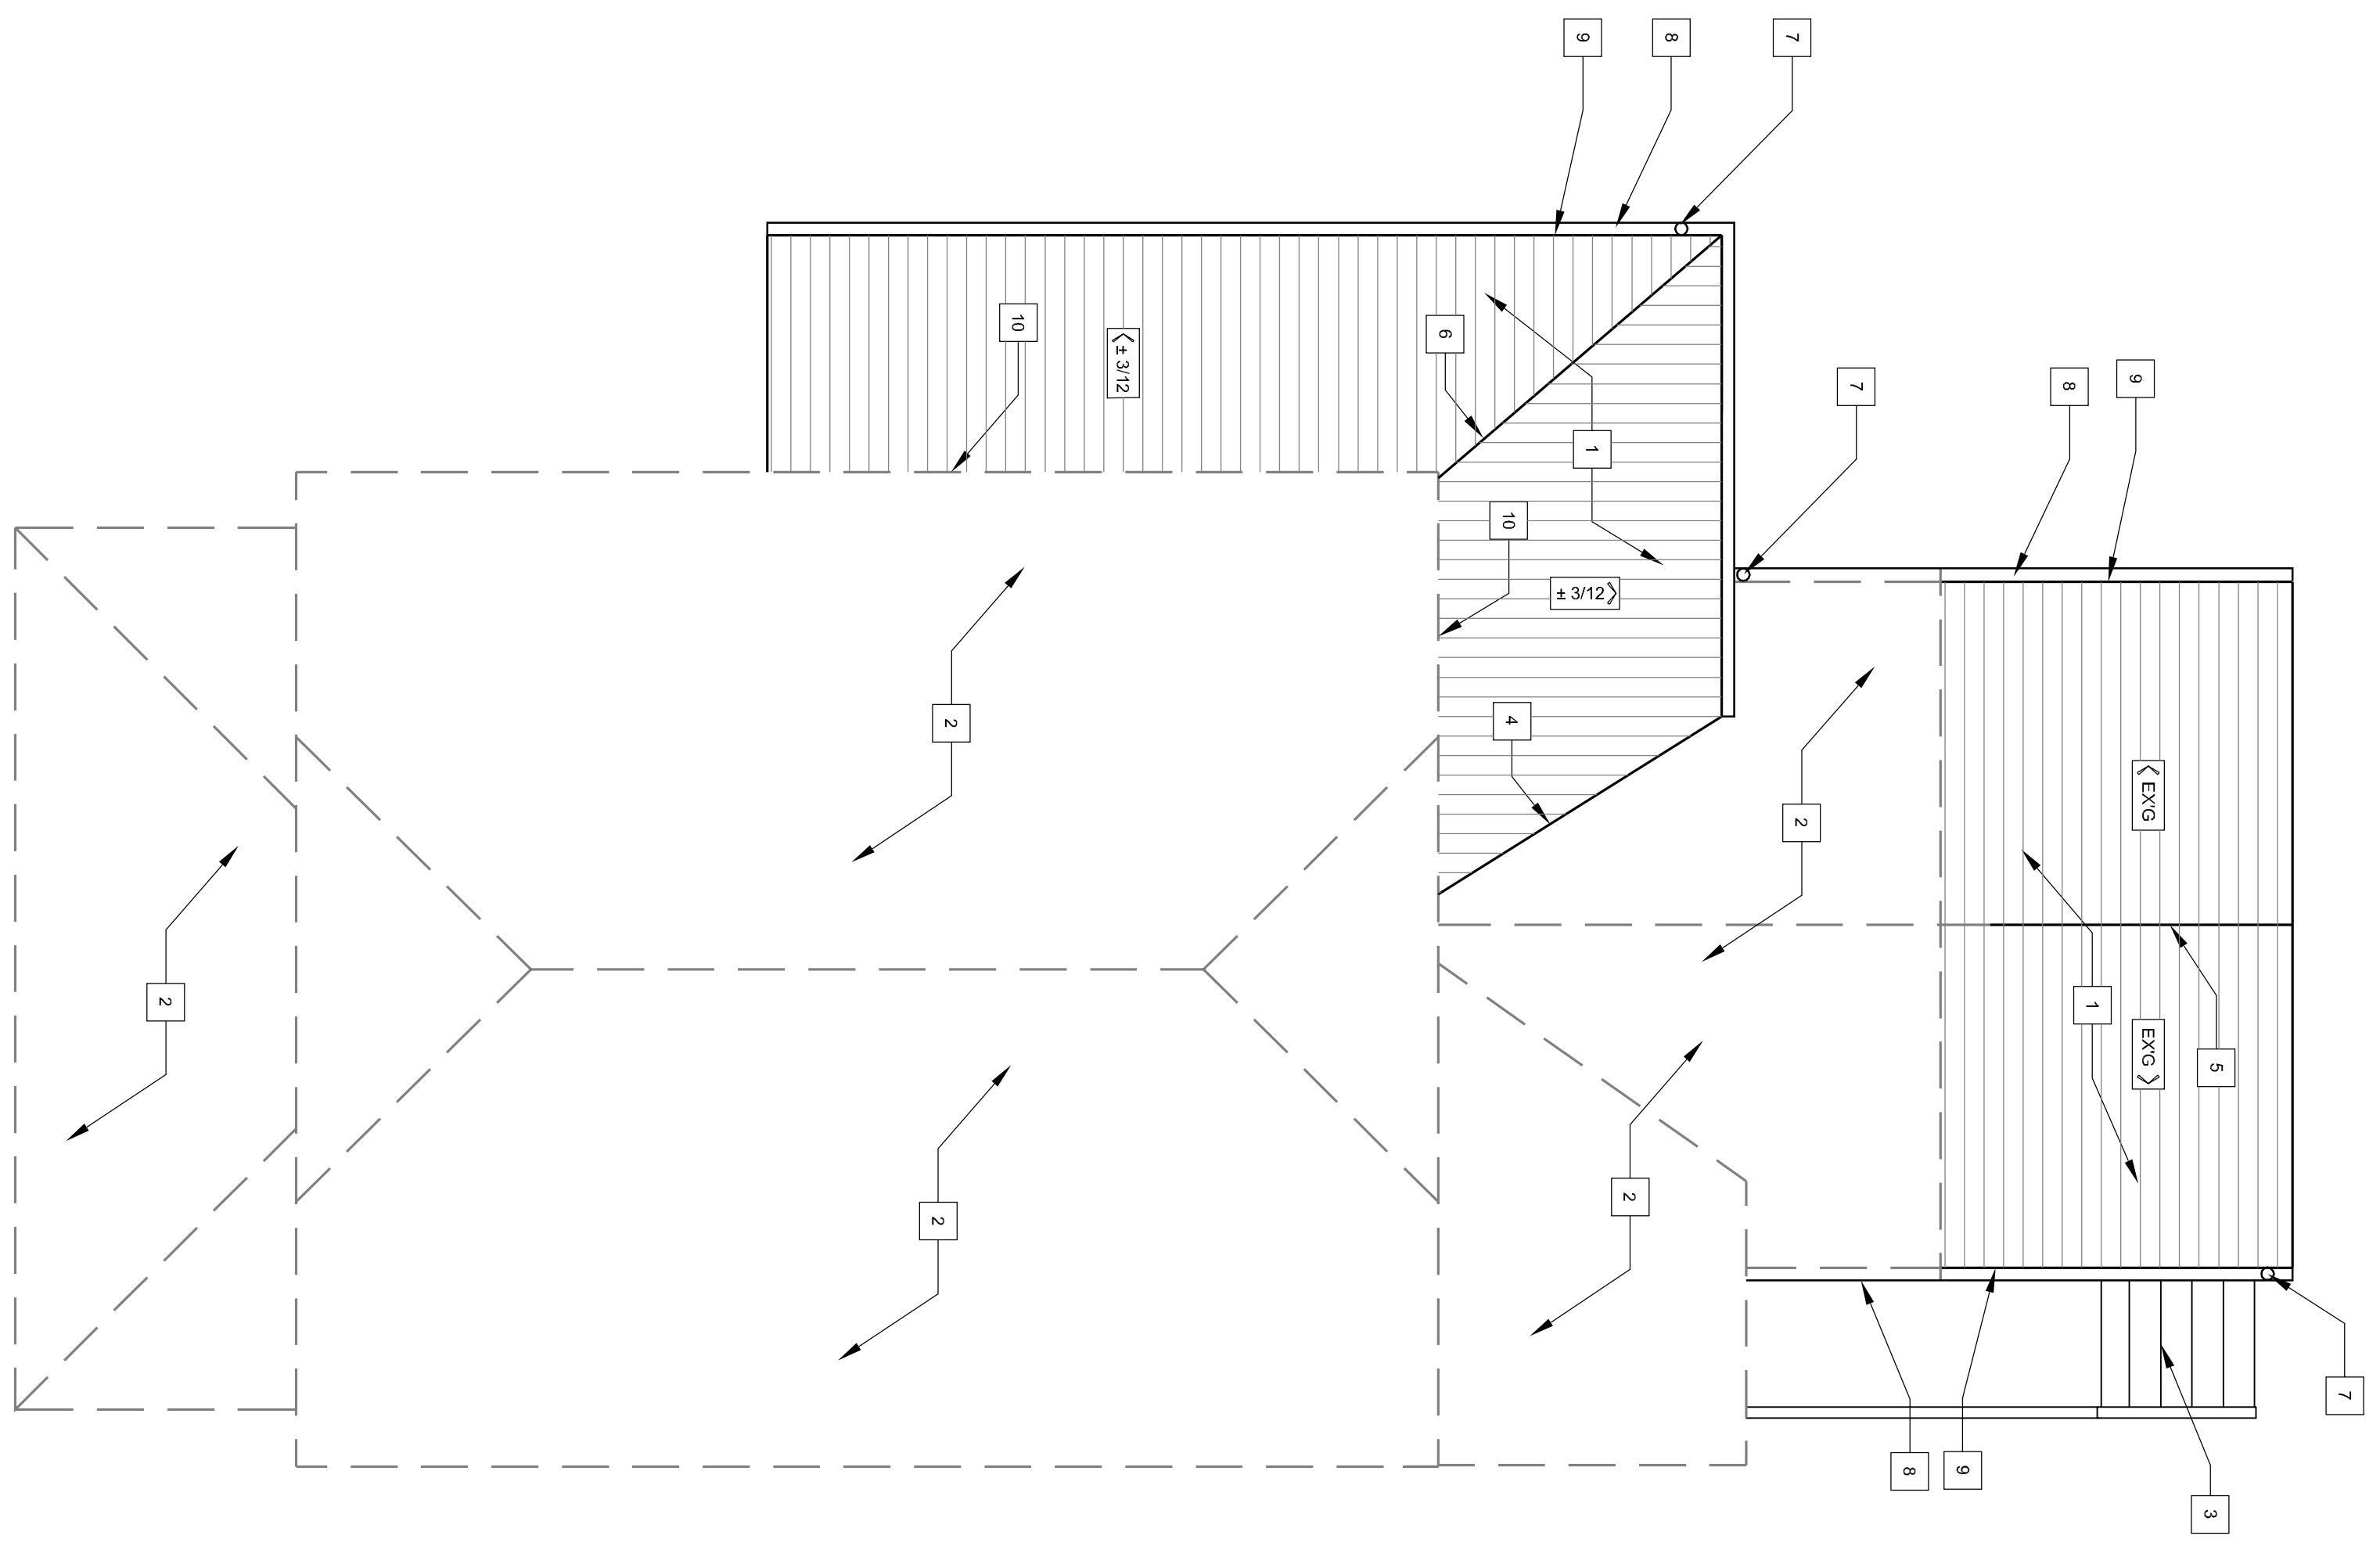

1 ROOF PLAN
1/4" = 1'-0"

- ROOF PLAN NOTES:**
- 1 NEW ROOF-SHINGLES P&S
 - 2 EXG ROOF-TO-REMAIN
 - 3 NEW W/D STEPS
 - 4 VALLEY'S AS NEEDED
 - 5 RIDGE LINE W/ RIDGE VENT AS NEEDED
 - 6 HIP AS NEEDED
 - 7 NEW SPOUT LOCATION, SPOUTS P&S
 - 8 GUTTERS P&S, SEE ELEVATIONS FOR ADDITIONAL GUTTERS & SPOUTS
 - 9 VENTED SOFFIT
 - 10 ROOF TO WALL VENT SYSTEM


ALL CONDITIONS AND DIMENSIONS CONTAINED HEREIN ARE APPROXIMATE. ALL TRADES PERSONS INVOLVED WITH THE WORK MUST FIELD VERIFY ALL PERTINENT INFORMATION, CONDITIONS AND DIMENSIONS. SEVERE DIFFERENCES SHALL BE BROUGHT TO THE ATTENTION OF MC DESIGN BUILD, LLC. THE BUILDER AND THE PROPERTY OWNER.
INFORMATION SHOWN ON THIS DOCUMENT INCORPORATES PROPRIETARY RIGHTS AND IS NOT TO BE DUPLICATED WHOLLY OR IN PART WITHOUT THE EXPRESS PERMISSION OF MC DESIGN BUILD, LLC.
DO NOT SCALE DRAWINGS

PHASE	DATE
EXG CONDITIONS	6-24-09
PRICE SET	10-28-09
PERMIT REVIEW	12-17-09
PERMIT REVIEW	9-27-12
PERMIT SET	

SHEET SCALE
X=1'-0"
OR AS NOTED

ROOF PLAN AND ELECTRICAL PLAN

SHEET NUMBER
A-3.0
OF 10/PL

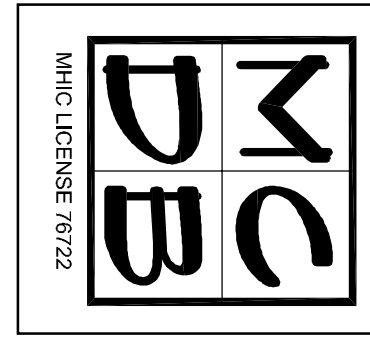

MC DESIGN BUILD, LLC
6 GEORGE STREET
GAITHERSBURG, MD 20877
OFFICE: 301-527-0700 FAX: 301-461-8644

MICHAEL & SYDEL
CAVANAUGH RESIDENCE
6 GEORGE STREET
GAITHERSBURG, MD 20877
MONTGOMERY COUNTY